


# GREY'S RIVER COVE

## PRELIMINARY PLAT AUGUST 2007


PROPERTY IS LOCATED IN TOWNSHIP 37 NORTH, RANGE 118 WEST,  
SECTION 29, LINCOLN COUNTY, WYOMING

### SHEET INDEX

- T1..... Title Sheet, Vicinity Map, and Sheet Index
- C1..... Topographic Survey
- C2..... Preliminary Plat
- C3..... Development Plan
- C4..... Preliminary Water & Sewer Plan
- C5..... Preliminary Wire Utilities Plan
- C6..... Preliminary Stormwater & Drainage Plan
- C7..... Details

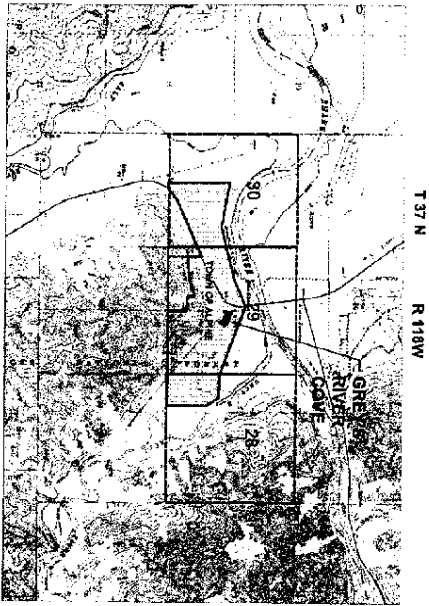


### EXISTING

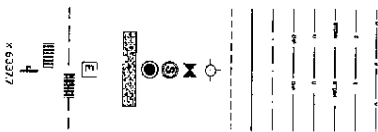

### LEGEND

- WATER
- SANITARY SEWER
- STORM SEWER
- UNDERGROUND POWER
- OVERHEAD POWER
- EASEMENT
- PROPERTY LINE
- EDGE OF ASPHALT
- FIRE HYDRANT
- WATER VALVE
- SANITARY MANHOLE
- STORM DRAIN MANHOLE
- STORM TRENCH DRAIN
- DIRECTION OF SURFACE RUNOFF
- JUNCTION VAULT / TRANSFORMER
- INDEX CONTOUR
- INTERIOR CONTOUR
- SIGN & POST
- SPOT ELEVATIONS
- EDGE OF GRAVEL
- SETBACK LINE

### PROPOSED

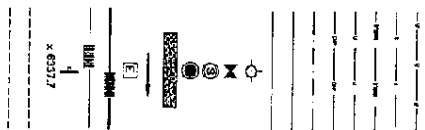

### PRELIMINARY PLANS

PROJECT TITLE:  
GREY'S RIVER COVE

DRAWING TITLE:  
TITLE SHEET, SHEET INDEX, AND  
VICINITY MAP



**RENDEZVOUS ENGINEERING, P.C.**

P.O. BOX 486 JACKSON, WYOMING 83201  
35 SOUTH GOOD VENTURE STREET  
PHONE: 307.730.2252 FAX: 307.733.2334


PROJECT BY: JJC

Date: 08/14/07

Rev: Date:

PROJECT NUMBER:  
07-2004

TOWNSHIP NUMBER:  
T1

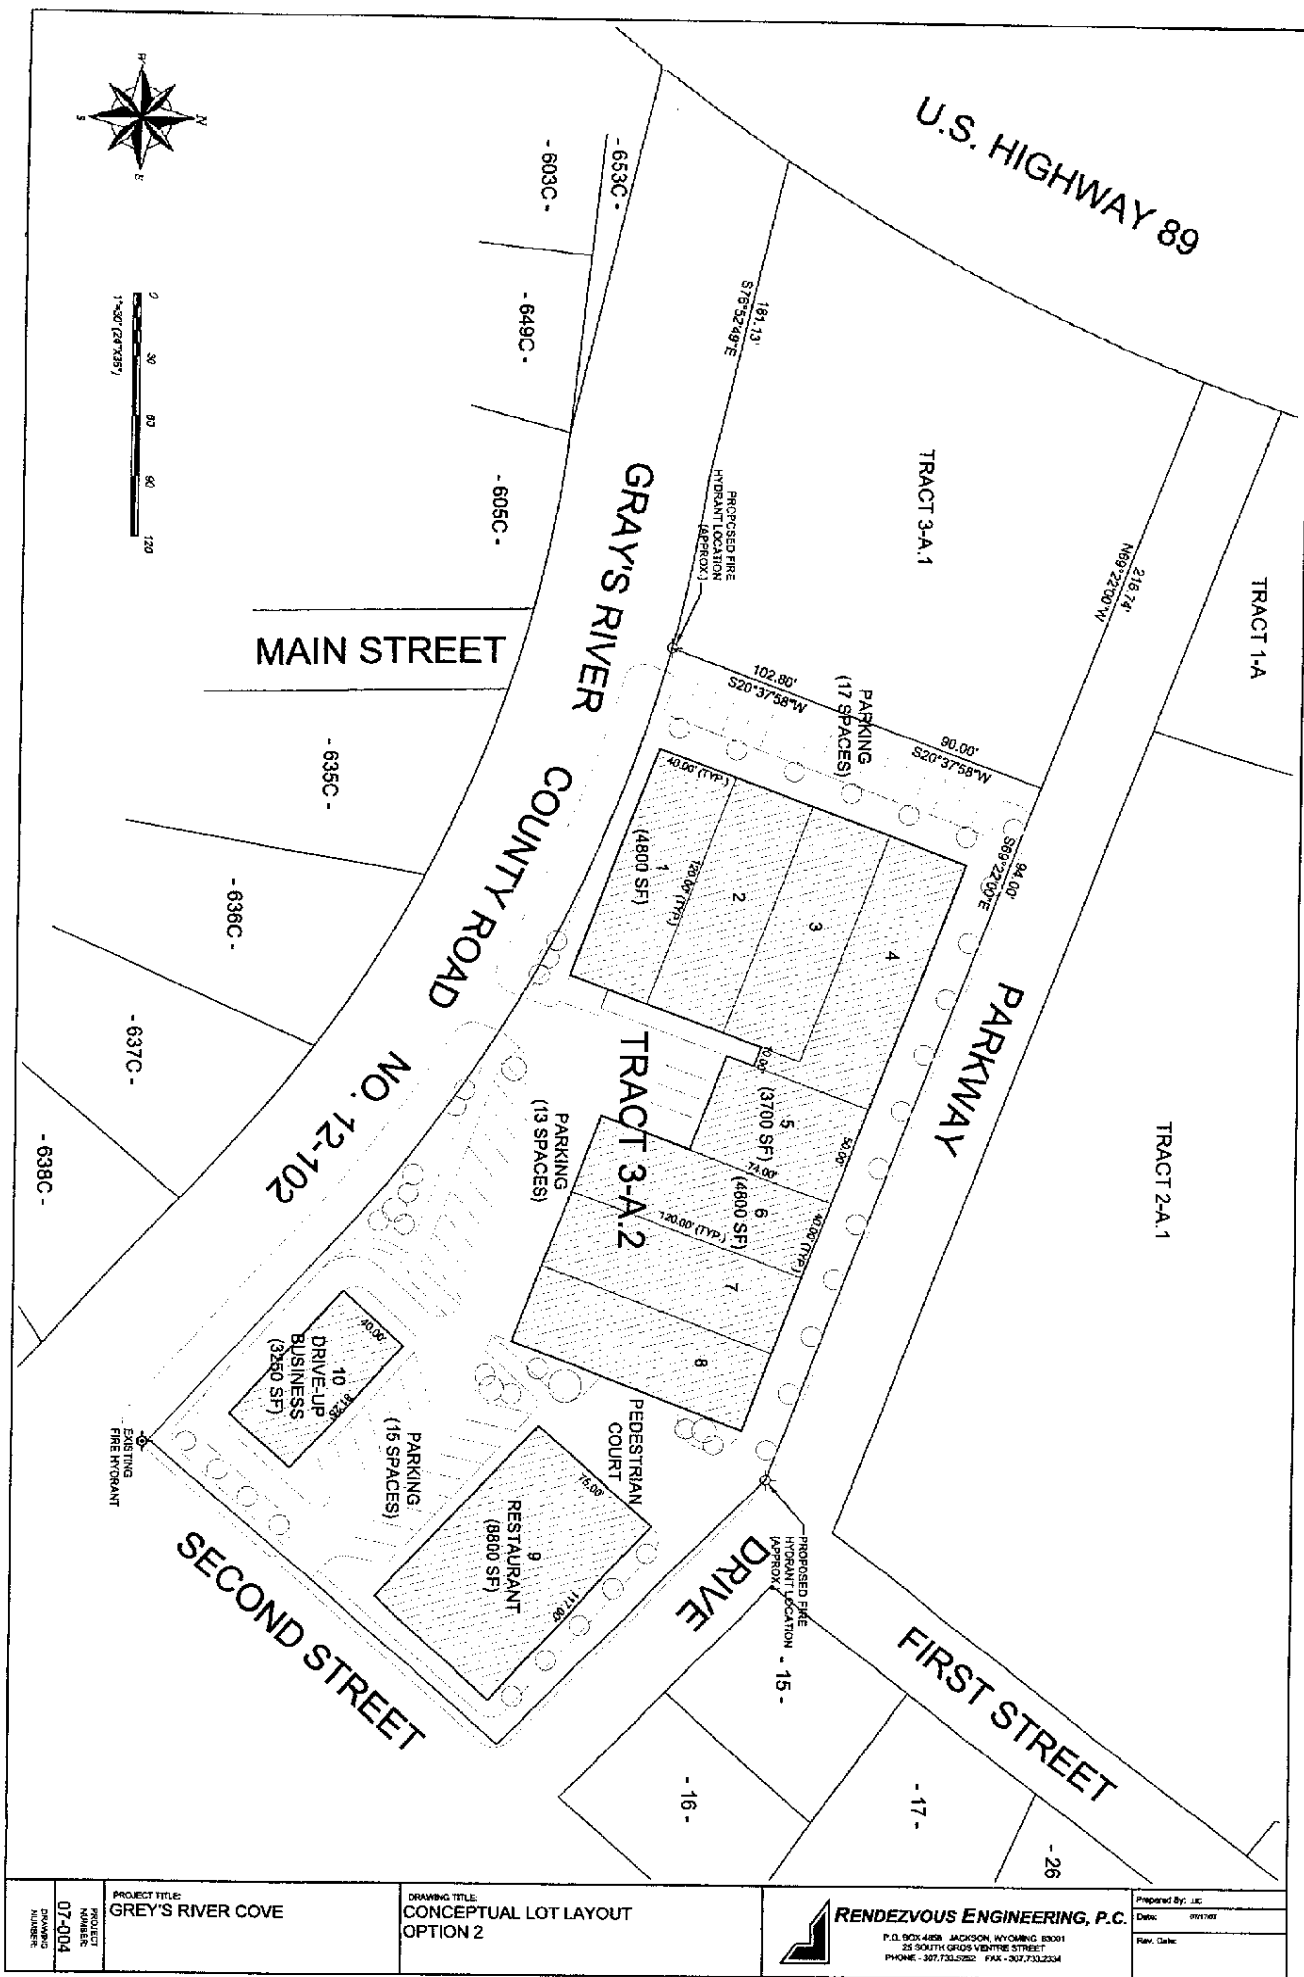

PROJECT TITLE:  
**GREY'S RIVER COVE**

PROJECT NUMBER:  
**07-004**

DRAWING NUMBER:


DRAWING TITLE:  
**CONCEPTUAL LOT LAYOUT  
 OPTION 2**

**RENDEZVOUS ENGINEERING, P.C.**

P.O. BOX 489 JACKSON, WYOMING 83001  
 25 SOUTH GROS VENTRE STREET  
 PHONE - 307.733.9292 FAX - 307.733.2304

Prepared By: J.C.  
 Date: 07/07/08

Rev. Date:

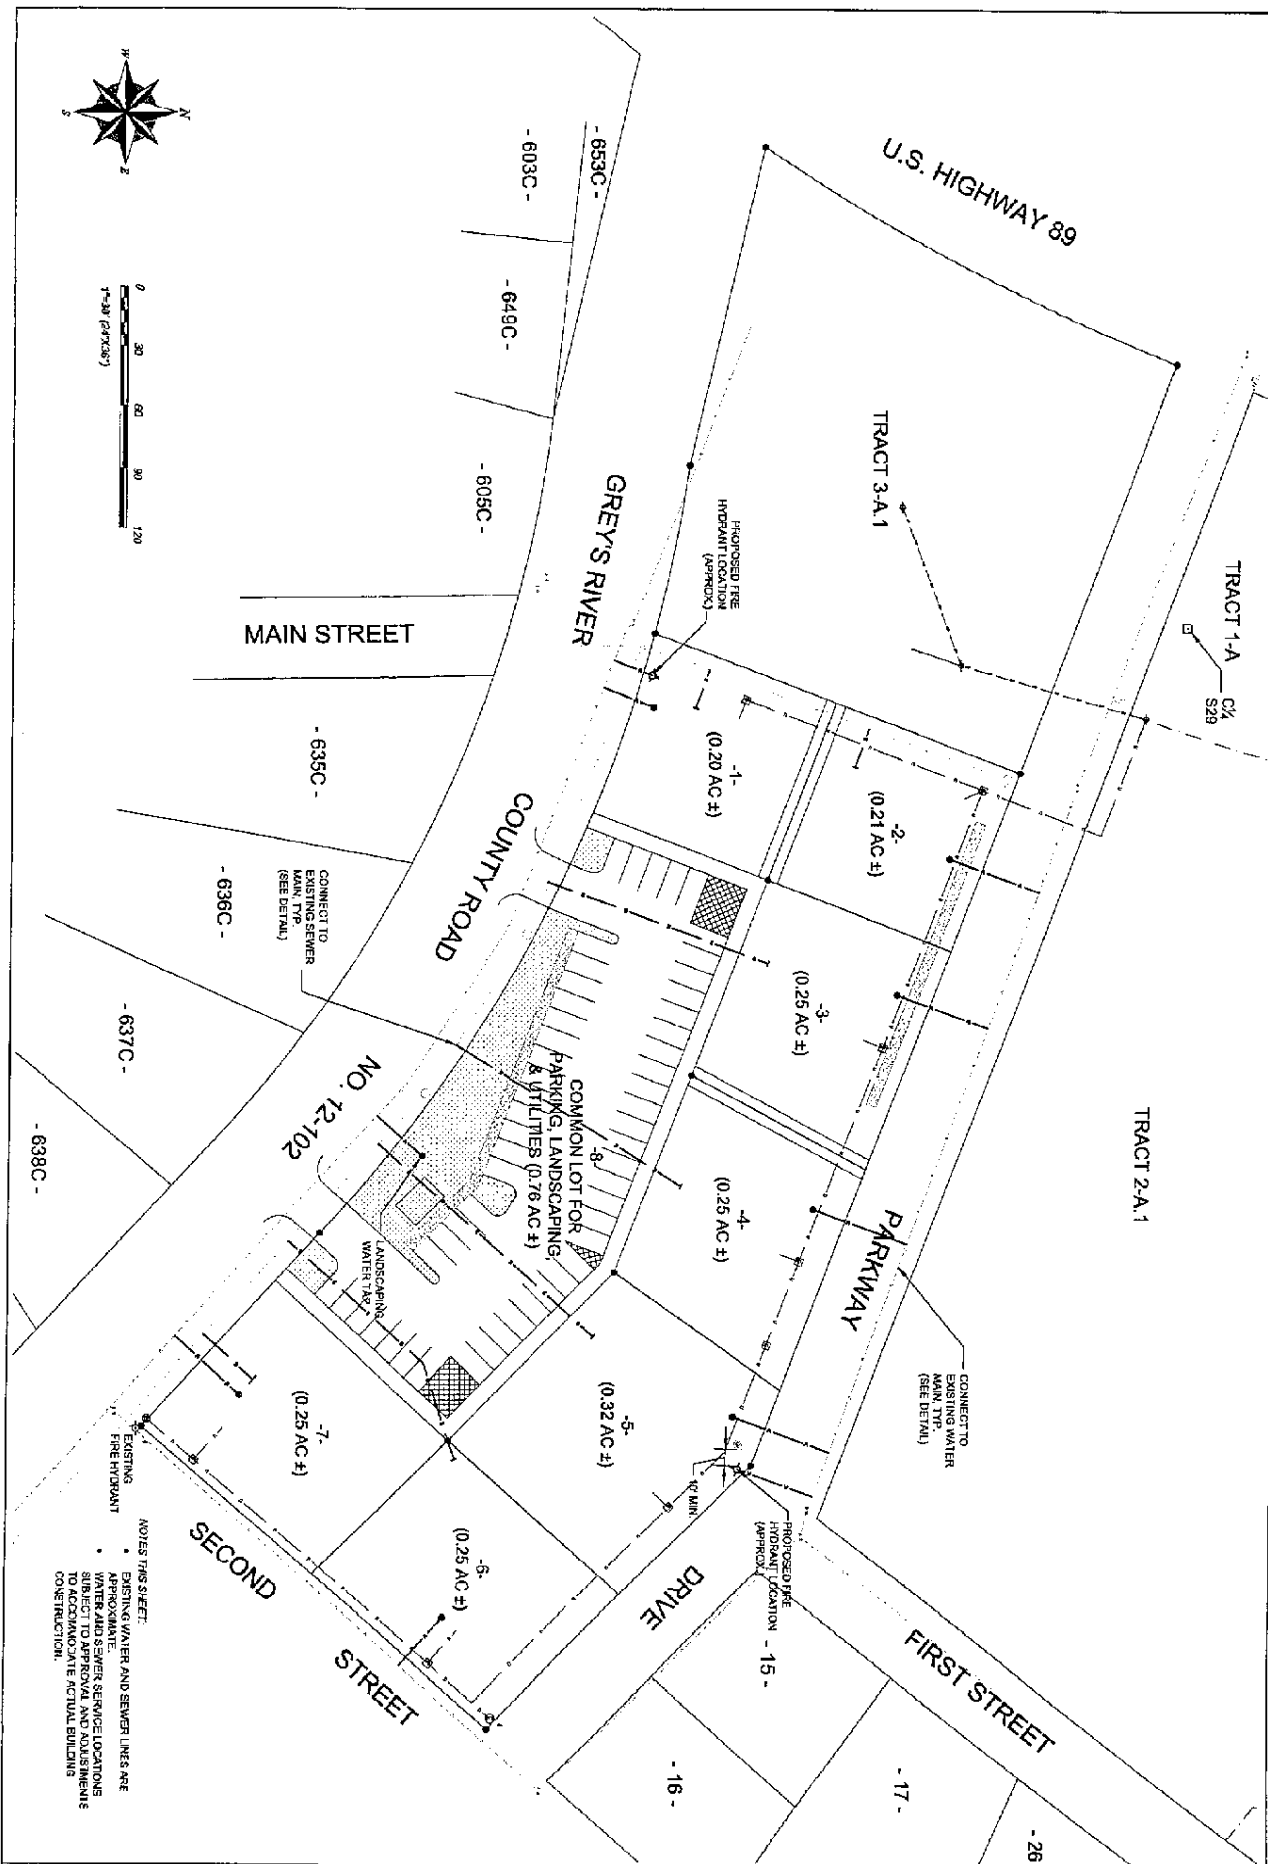

MAIN STREET

U.S. HIGHWAY 89

GREY'S RIVER

COUNTY ROAD

NO. 12-102

COMMON LOT FOR  
PARKING, LANDSCAPING  
& UTILITIES (0.76 AC ±)

PARKWAY

SECOND STREET

DRIVE

FIRST STREET

NOTES THIS SHEET:  
 • EXISTING FIRE HYDRANT  
 • APPROXIMATE WATER AND SEWER SERVICE LOCATIONS SUBJECT TO APPROVAL AND ADJUSTMENTS TO ACCOMMODATE ACTUAL BUILDING CONSTRUCTION.

PROJECT NUMBER 07-004 DRAWING NUMBER C4	PROJECT TITLE GREY'S RIVER COVE	DRAWING TITLE PROPOSED WATER AND SEWER	RENDEZVOUS ENGINEERING, P.C. P.O. BOX 6006, JACKSON, WYOMING 85001 25 SOUTH GARDEN VENTURE STREET PHONE - 307.733.6262 FAX - 307.735.2334	Prepared By: JLT Date: 10/20/07 Rev. Date:
--	------------------------------------	---	--	--